




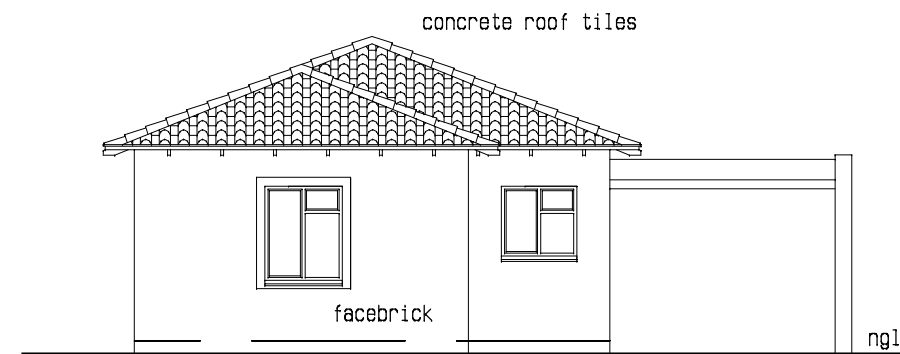


South Elevation 1:100

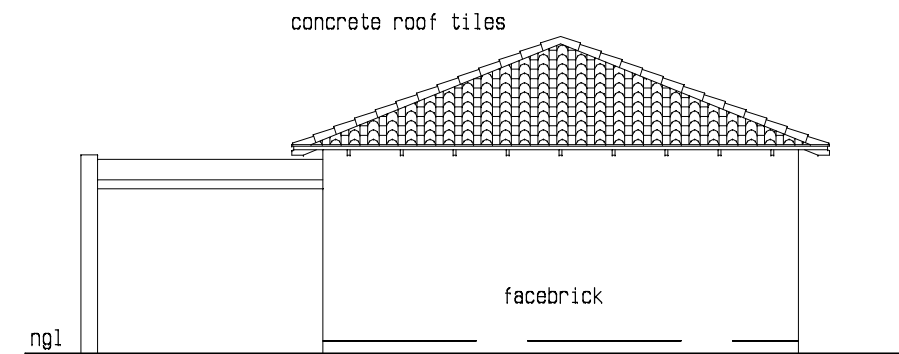


North Elev 1:100

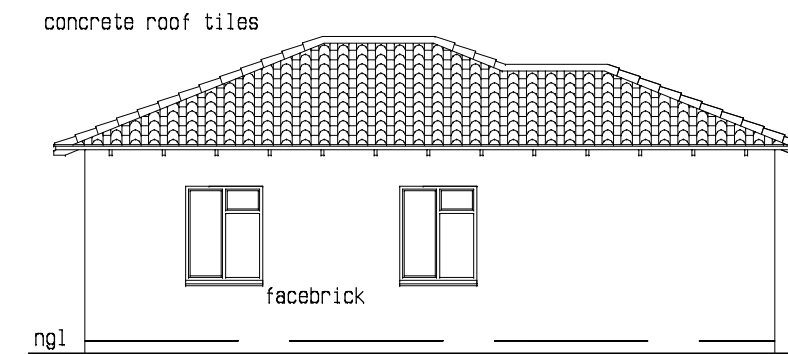

West Elev 1:100

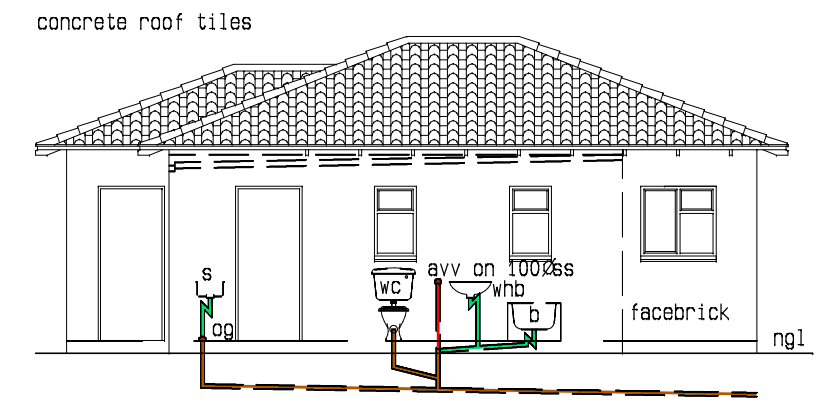


East Elev 1:100

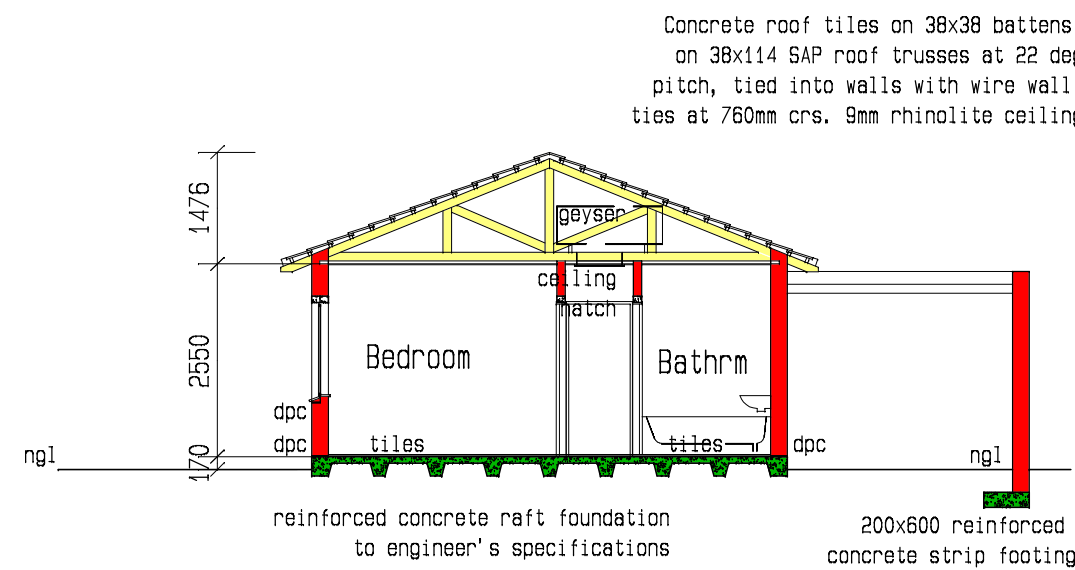


Section AA 1:100


1022	1245	W1	qty:3
		Description:	
		Factory made steel window	
		with red oxide finish	
		Ironmongry: Ex-factory	
		Glazing: clear	
1022	949	W2	qty:2
		Description:	
		Factory made steel window	
		with red oxide finish	
		Ironmongry: Ex-factory	
		Glazing: clear	
553	924	W3	qty:2
		Description:	
		Factory made steel window	
		with red oxide finish	
		Ironmongry: Ex-factory	
		Glazing: obscure	

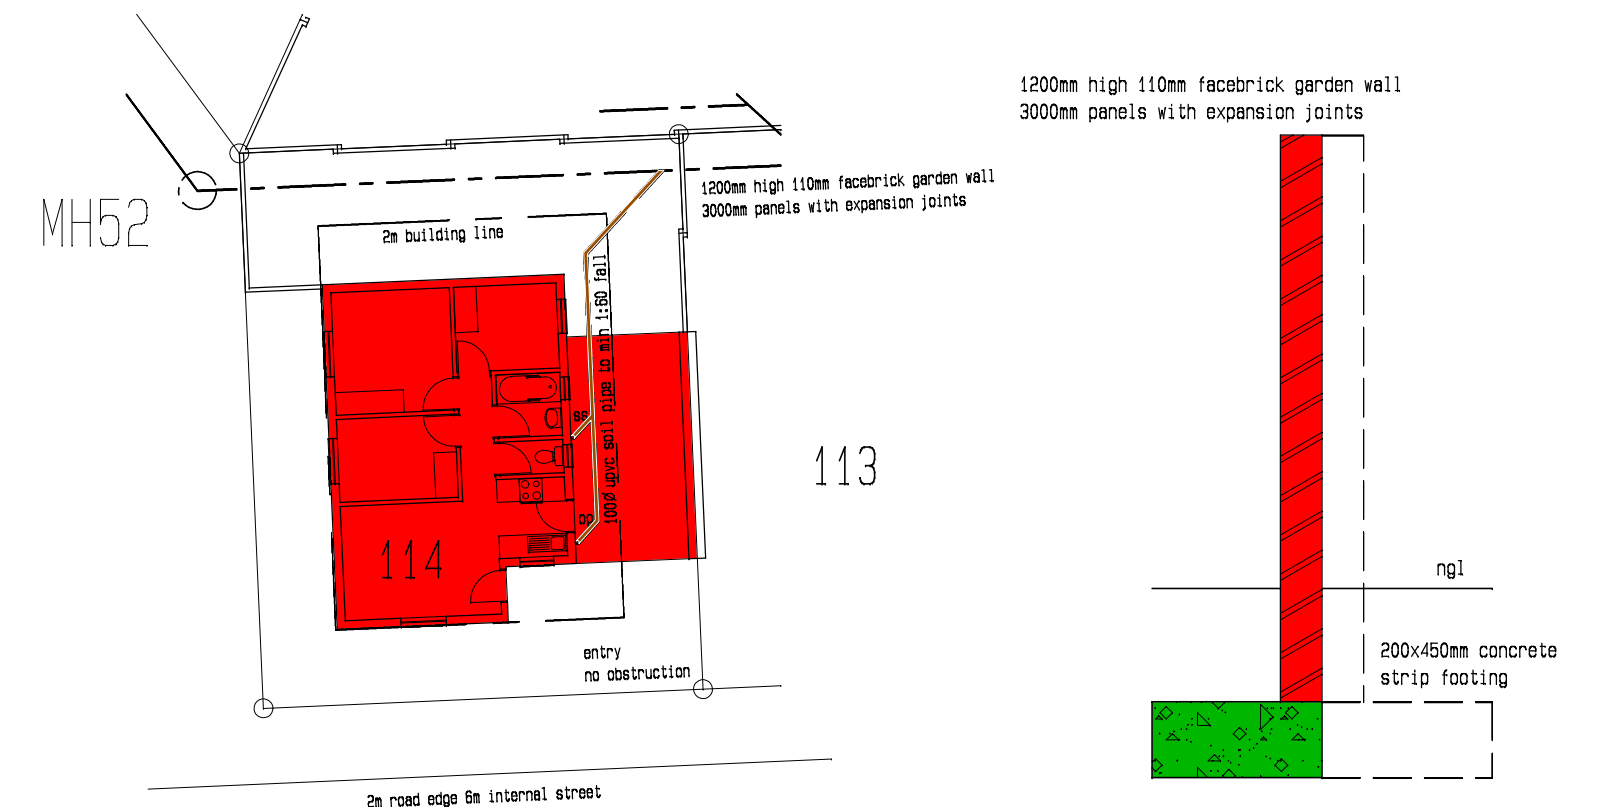

Site Plan 1:200

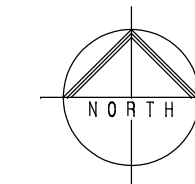


Boundary wall 1:20

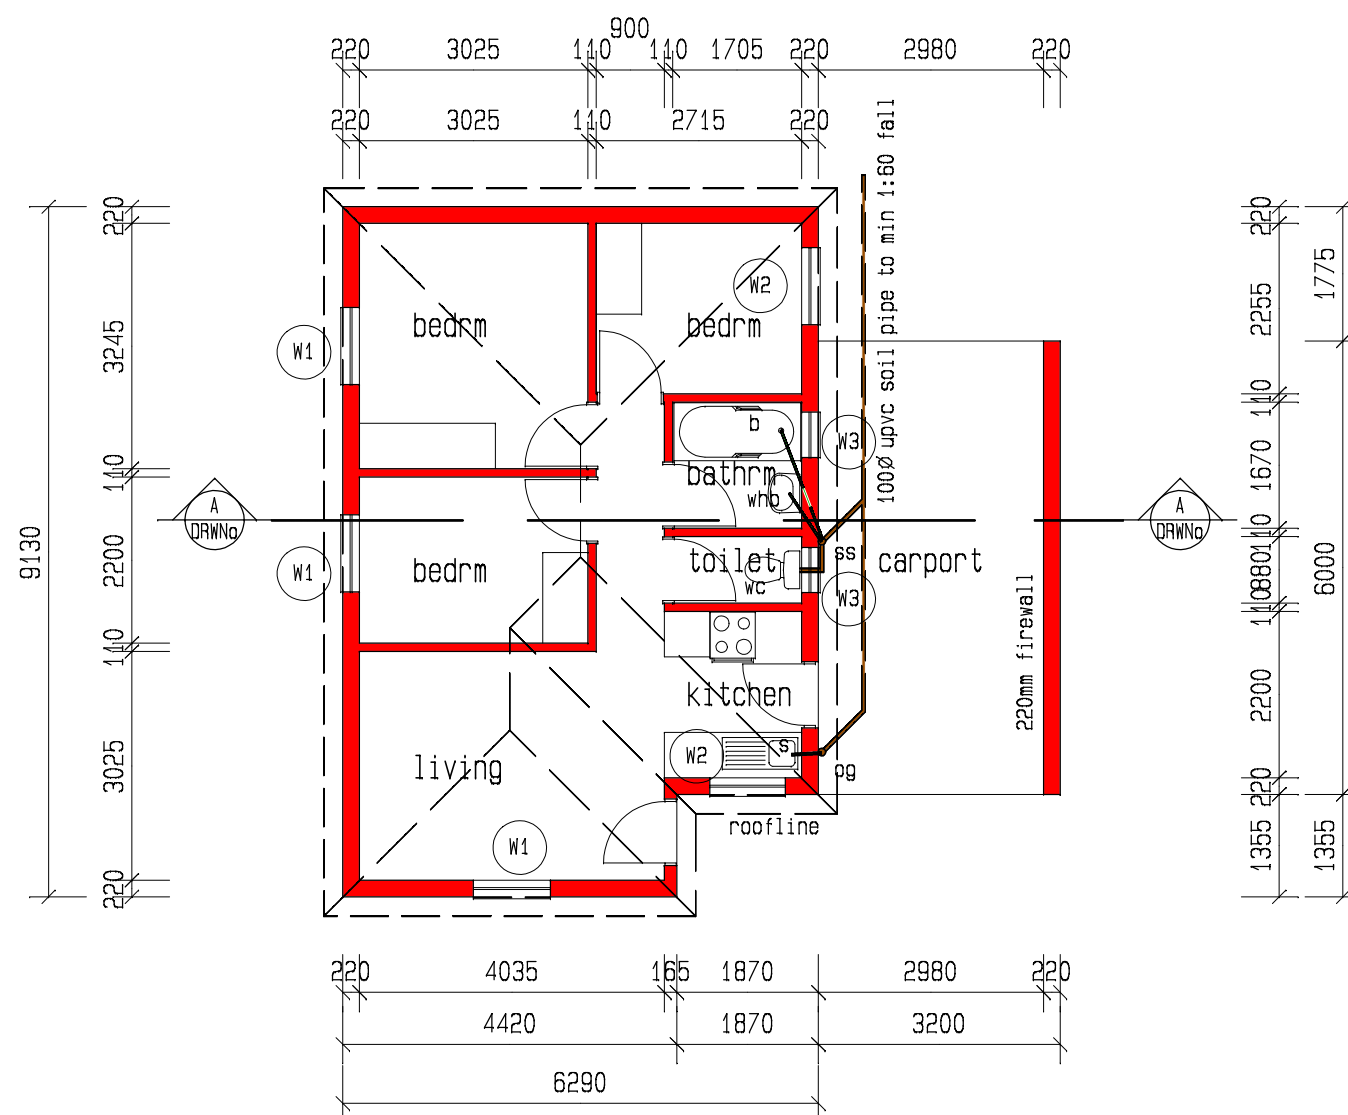

Plan 1:100

Electrical Plan 1:100

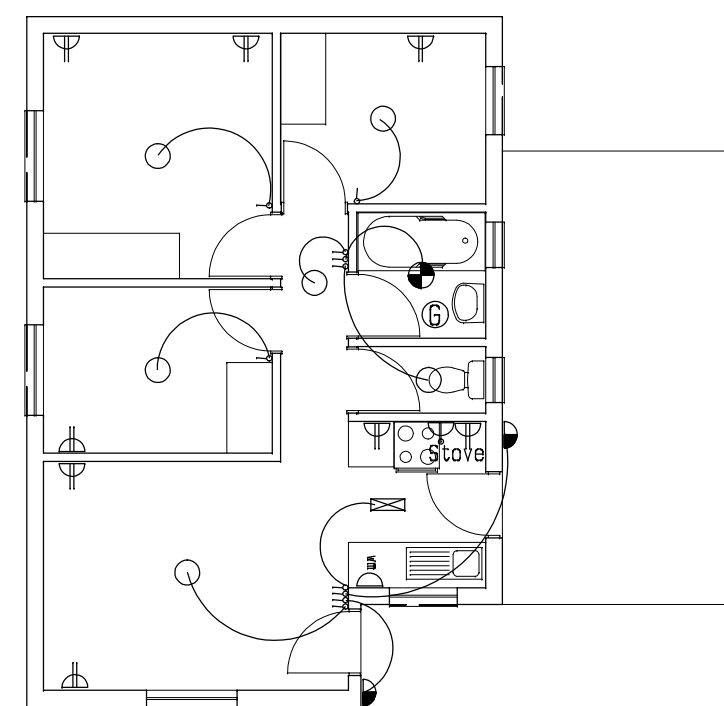

ELECTRICAL KEY:	
Waterproof ceiling mounted fitting	Geysers point in roof volume
Waterproof wall mounted fitting 1900mm	Double 15A wall socket, 340mm or 1105mm
Standard ceiling mounted fitting	Wall light switch 1105mm
Standard wall mounted fitting 1900mm	40A stove switch to left of stove 1105mm
Ceiling mounted flourescent fitting	15A washing machine switch 1105mm, socket 340mm

Note:
 *All differences between floor level inside and ground level outside min. 170
 *Dpc's under all windows and at surface bed level
 * Min IL height to be 450mm

PLANNING KEY:	Building area	55m ²
	Garage/carport	18m ²
	Total	73m ²
	Coverage	43%
	FAR	0.3
	Single storey	

Typical type 2 unit on Ptn of Ptn 3,
 Erf 1948, Evander for Sikunye Holdings (Pty) Ltd



Drawn By: jd
 Date: 06 / 2014
 Project No: 2912

Drawing ref. no.

T2